


- NOTES:
- DO NOT SCALE. USE FIGURED DIMENSIONS ONLY.
  - THIS DRAWING IS TO BE READ IN CONJUNCTION WITH ALL OTHER RELEVANT ARCHITECTURAL AND ENGINEERING DRAWINGS.

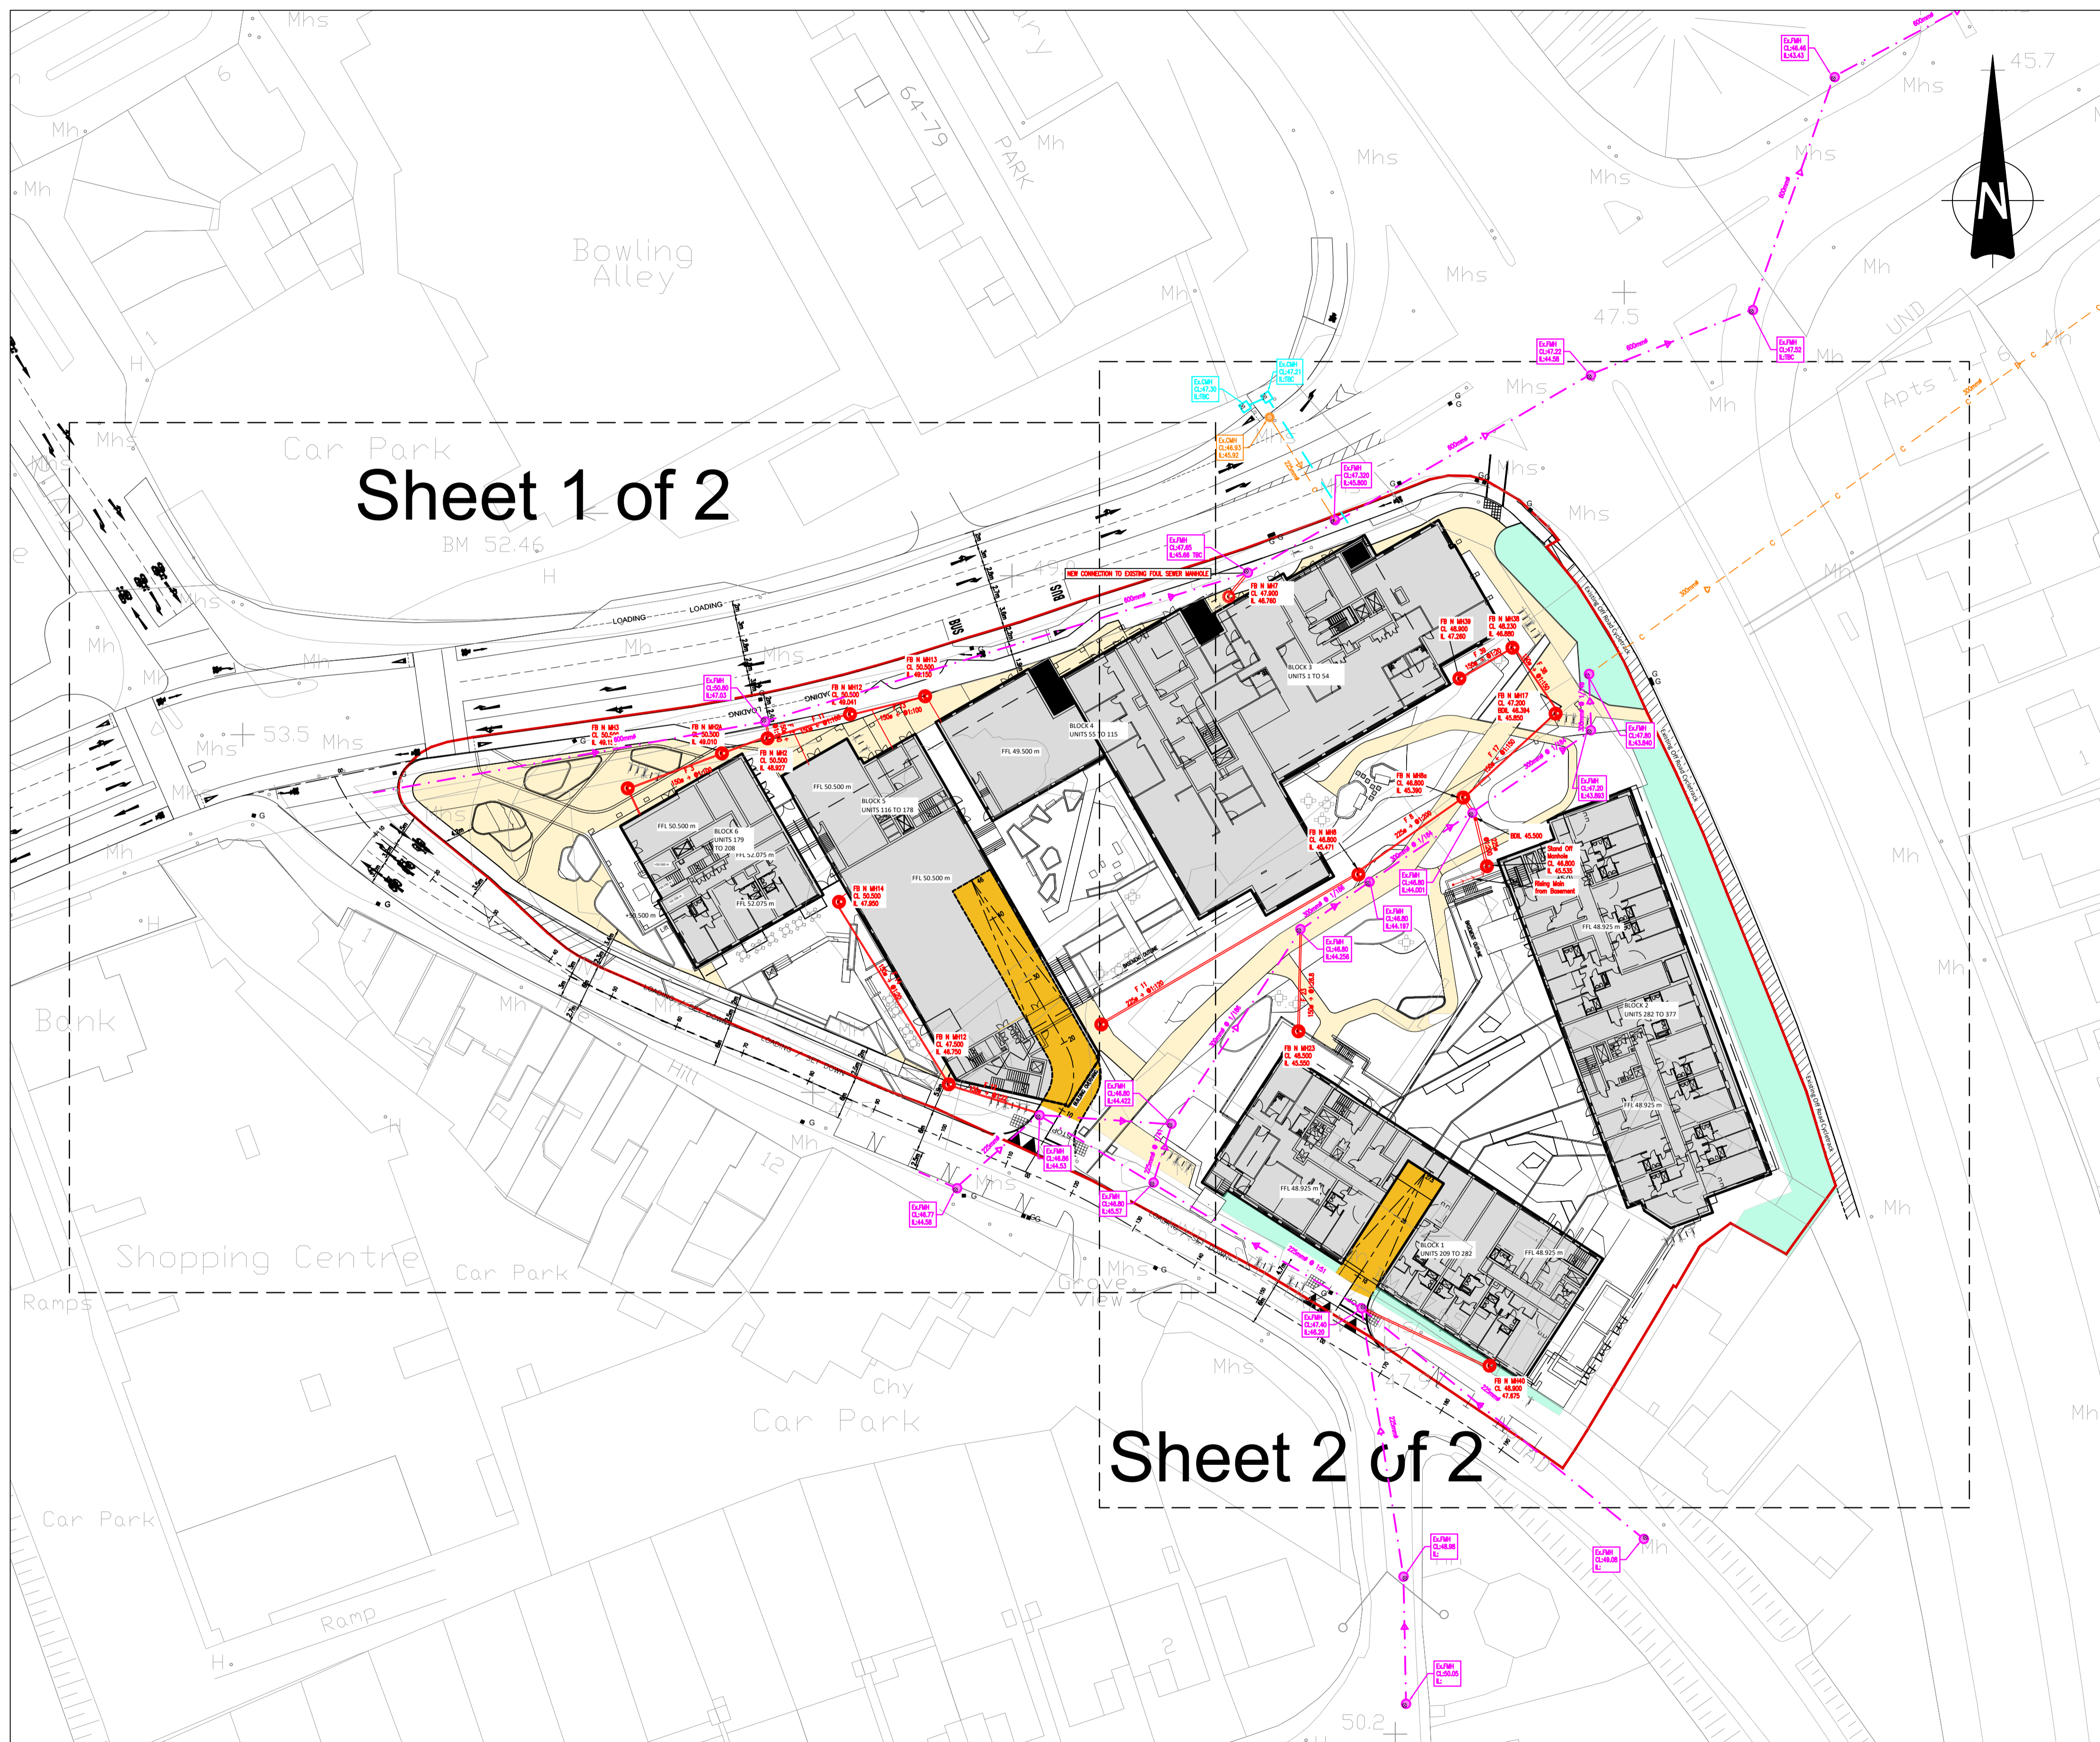


**LEGEND**

- 150mm Ø 1:150 FMH 1 PROPOSED FOUL WATER SEWER & MANHOLE WITH MANHOLE REFERENCE, COVER & INVERT LEVEL.
- c --- EXISTING COMBINED SEWER
- --- EXISTING FOUL WATER SEWER

NOTE:  
PUBLIC FOUL PIPE MATERIAL TO BE U-PVC (STIFFNESS CLASS 8) AND IN COMPLIANCE WITH SECTION 3.13 OF IRISH WATER CODE OF PRACTICE.

NOTE:  
FOUL SEWERS TO BE CONSTRUCTED WITH CONCRETE SURROUND IN ACCORDANCE WITH IRISH WATER STD-WW-08 WHERE VERTICAL CLEARANCE FROM SURFACE WATER IS LESS THAN 300mm AND WHERE DEPTH OF COVER TO ROAD IS LESS THAN 1.2m

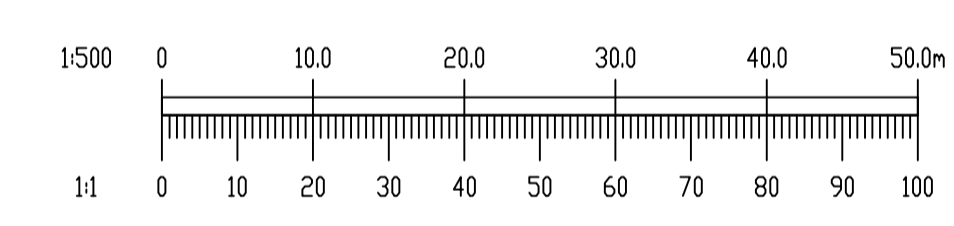

| REV. | DATE | AMENDMENT | DRN | APPD |
|------|------|-----------|-----|------|
|      |      |           |     |      |

STATUS **FOR PLANNING ONLY  
NOT FOR CONSTRUCTION**

**Waterman Moylan**  
Engineering Consultants

BLOCK 5, EASTPOINT BUSINESS PARK, ALFIE BYRNE ROAD,  
DUBLIN D03 H3F4 IRELAND. Tel: (01) 664 8900  
Email: info@waterman-moylan.ie www.waterman-moylan.ie

CLIENT CAIRN HOMES

ARCHITECT OMP ARCHITECTS

PROJECT BLAKES RESIDENTIAL DEVELOPMENT,  
STILLORGAN,  
CO. DUBLIN.

TITLE  
**PROPOSED FOUL WATER DRAINAGE LAYOUT  
GA PLAN**

|                    |                   |                  |                  |
|--------------------|-------------------|------------------|------------------|
| DRAWN<br>G.Byrne   | DESIGNED<br>EN    | APPROVED<br>BG   | DATE<br>MAR. '22 |
| SCALE<br>1:500 @A1 | JOB NO.<br>20-071 | DRG. NO.<br>P123 | REVISION         |

PLAN VIEW  
PROPOSED FOUL WATER DRAINAGE LAYOUT – GA PLAN  
SCALE 1:500 @A1